

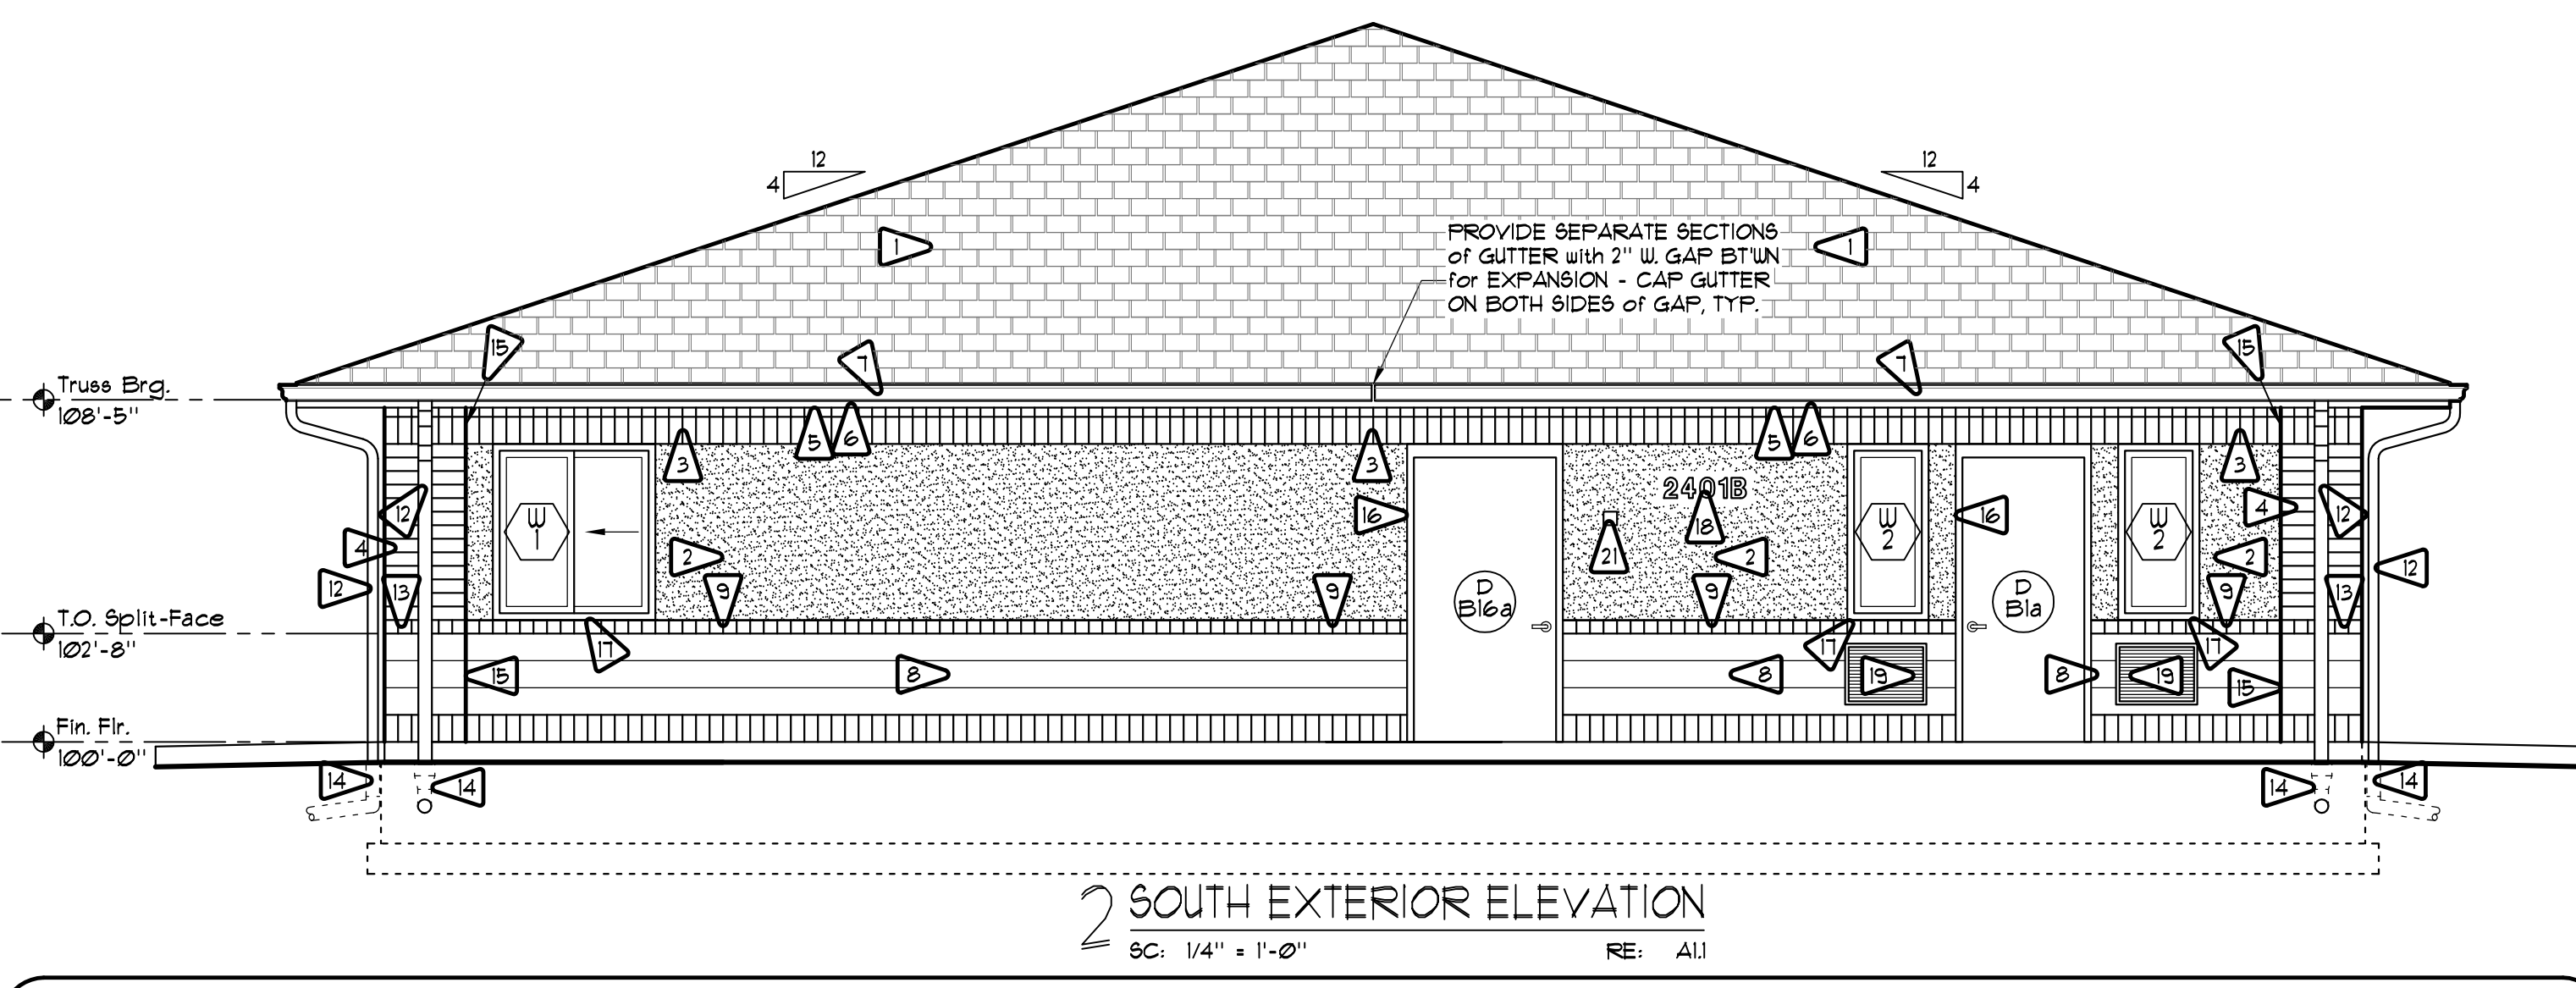
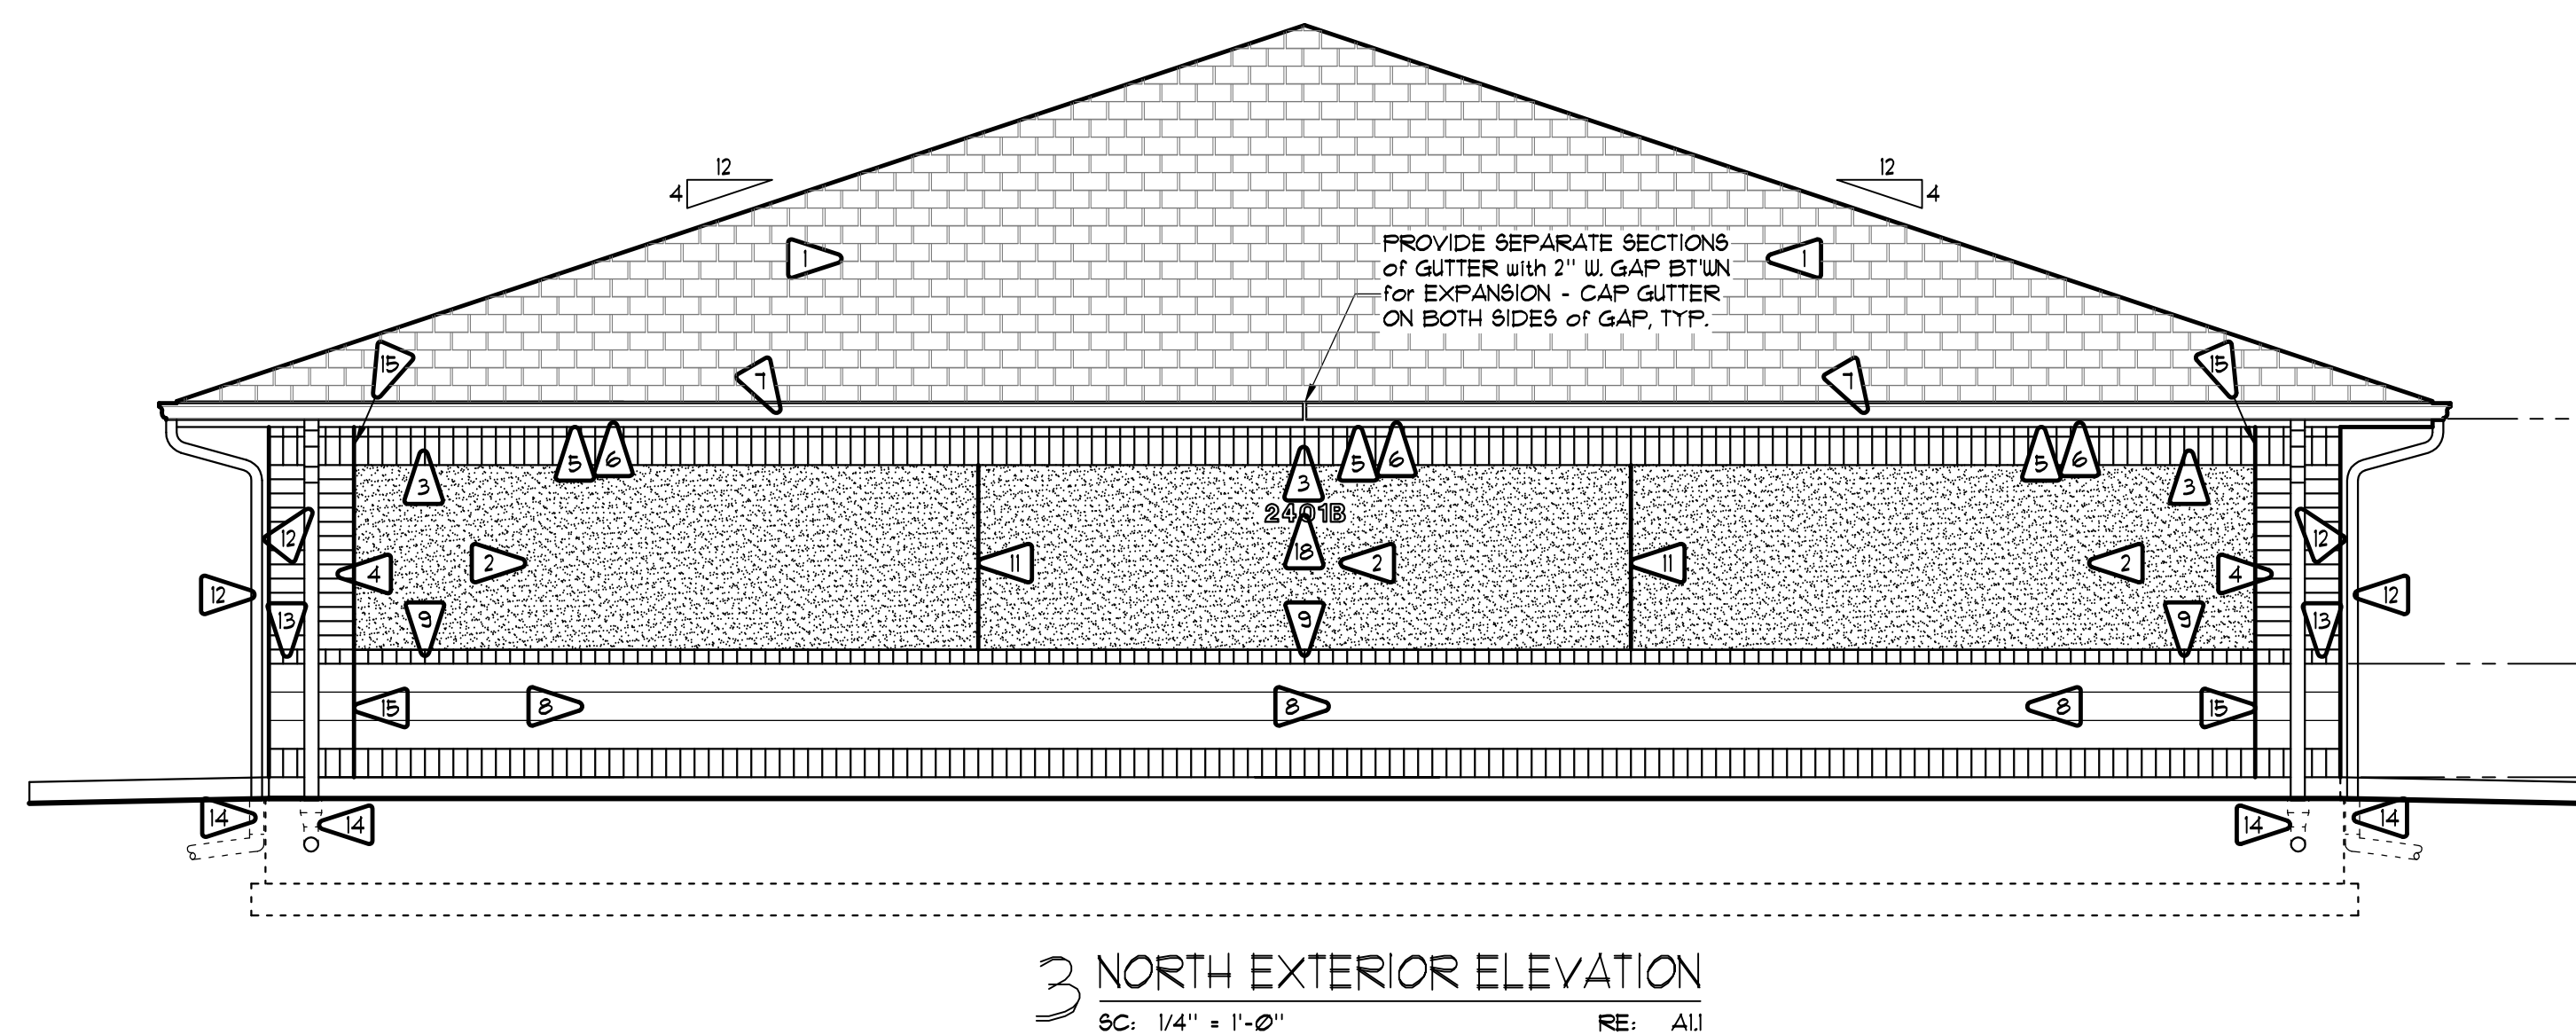


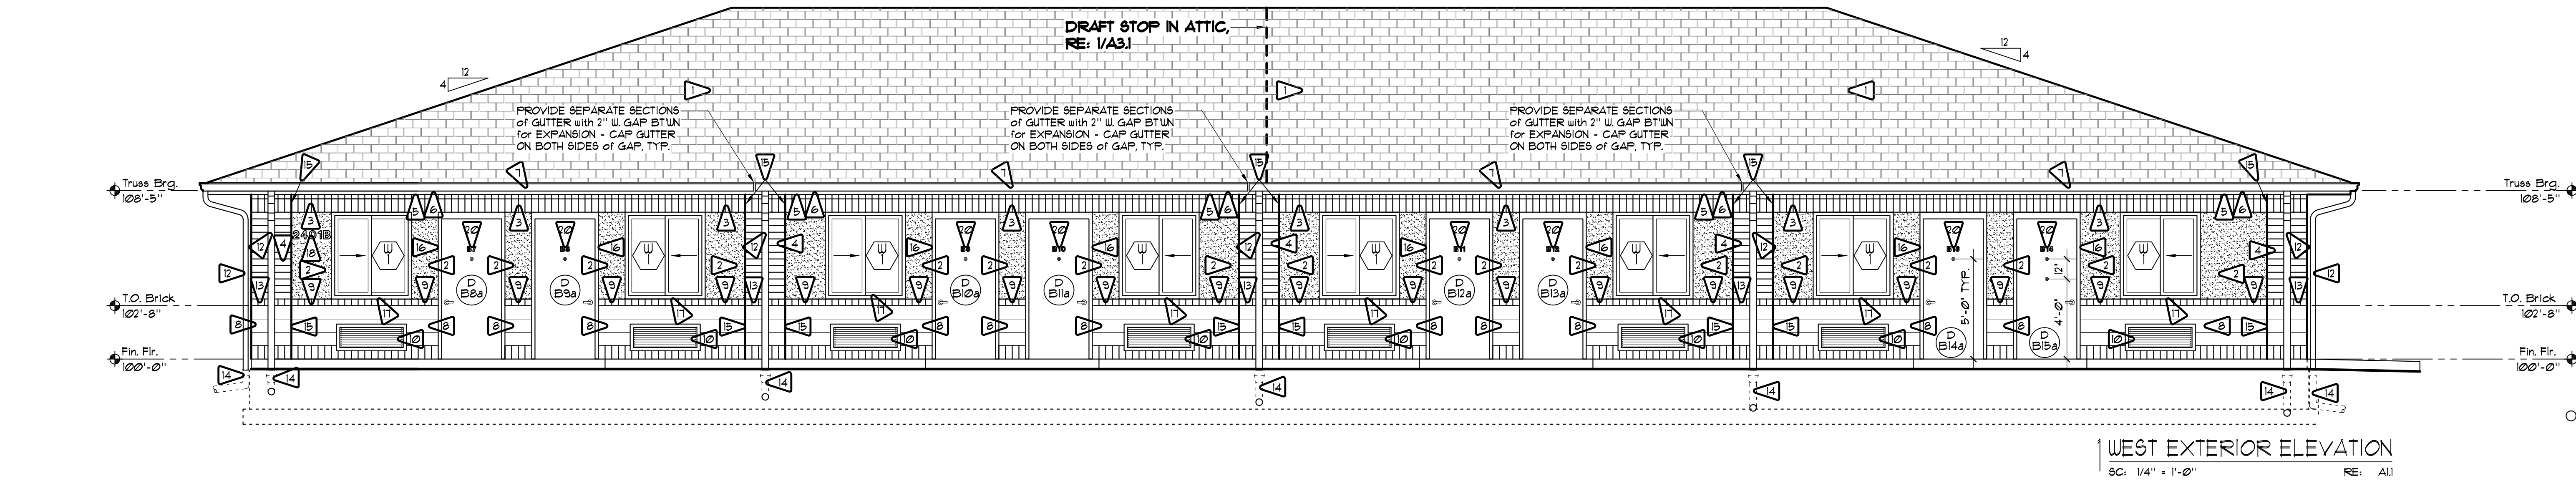

EXTERIOR ELEVATION FLAG NOTES THIS SHEET ONLY	
1	TYPICAL ROOF CONSTRUCTION: CLASS A "GAF/ELK 40 YR HIGH PROFILE ASPHALT SATURATED ORGANIC FELT SHINGLES, COLOR TO BE SELECTED FROM MANUF. FULL RANGE. (or Approved Equal) on (1) LAYER 30 lb. FELT on 23/32" FLY UD. ROOF SHEATHING on PRE-ENGINEERED STEEL ROOF TRUSSES at 24" O.C. with R-38 (MIN) FOIL FACED BATT INSUL. - PROVIDE "W/ GRACE" ICE and WATER SHIELD MEMBRANE UP 16" at ALL VALLEYS (BOTH SIDES, 16" UP FROM ALL EAVES, and 16" DOWN ALL RIDGES (BOTH SIDES).
2	TYP. EXTERIOR WALL CONSTRUCTION: PORTLAND CEMENT PLASTER-BASED THREE-COAT STUCCO SYSTEM on METAL LATH on (2) LAYER ASPHALT SATURATED KRAFT GRADE "D" SHEATHING PAPER (JUMBO-TEX or EQUAL) on 1/2" DENSGLASS SHEATHING on 2" CONT. RIGID INSULATION SET BETWEEN 2" 25 ga. Z-FURRING at 2'-0" O.C. on 1/2" DENSGLASS SHEATHING on 6" 18 ga. STRUCT. STL. STUDS at 16" O.C. STUCCO COLOR TO MATCH "OMEGA FLEX" COLOR TO BE SELECTED FROM MANUFACTURERS FULL RANGE.
3	4x4x8 DOUBLE SOLDIER COURSE, CUT TOP BRICK as NECESSARY to FIT WALL WIDTH. SLOPE AWAY FROM WINDOW and BUILDING. RE: 4/A3.1.
4	TYP. BRICK PILLASTER: 4x4x8 BRICK OVER 1/2" AIR SPACE OVER 3/8" DRAINAGE BD. on 2" CONT. R-13 RIGID INSULATION SET BETWEEN 2" 25 ga. Z-FURRING at 2'-0" O.C. on 1/2" DENSGLASS SHEATHING on 6" 18 ga. STRUCT. STEEL STUDS at 16" O.C.
5	TYP. EXTERIOR SOFFIT: 12" W, 24 ga. PRE-FORMED, PRE-FINISHED, SMOOTH TEXTURE, FLUSH SEAM PANEL SYSTEM with V-GROOVE and CONCEALED FASTENERS on 3/8" 25 ga. HAT CHANNELS at 2'-0" O.C. on PRE-ENGINEERED STEEL TRUSSES. COLOR TO BE SELECTED BY ARCHITECT FROM MANUF. FULL RANGE.
6	TYP. EXTERIOR FASCIA: PRE-FINISHED, 24 ga. MTL. FASCIA PANEL with DRIP EDGE and CONT. CLEAT at BOTTOM OVER METAL SUB-FASCIA. COLOR TO BE SELECTED BY ARCHITECT FROM MANUF. FULL RANGE.
7	TYP. GUTTER: 24 ga. PRE-FORMED, PRE-FINISHED STEEL GUTTER. COLOR TO BE SELECTED FROM MANUFACTURERS FULL RANGE.
8	TYP. EXTERIOR WAINSCOT: 4x4x8 BRICK SOLDIER COURSE BASE with 4x8x16 GROUND-FACED CMU ABOVE OVER 1/2" AIR SPACE OVER 3/8" DRAINAGE BD. on 2" CONT. R-13 RIGID INSULATION SET BETWEEN 2" 25 ga. Z-FURRING at 2'-0" O.C. on 1/2" DENSGLASS SHEATHING on 6" 18 ga. STRUCT. STEEL STUDS at 16" O.C. - CMU COLOR TO BE SELECTED FROM MANUF. FULL RANGE. GROUT COLOR TO BE SELECTED FROM DAVIS COLOR FULL RANGE.
9	4x4x8 CONT. ROWLOCK BRICK SILL. CUT as NECESSARY to FIT WALL WIDTH. SLOPE AWAY FROM WINDOW and BUILDING. RE: 4/A3.1.
10	P-TAC UNIT: THRU-THE-WALL PACKAGED THERMAL HEAT and AC UNIT (P-TAC) with EXTERIOR GRILLE, RE: MECHANICAL (HVAC) DRAWINGS.
11	STUCCO EXPANSION JOINT: PRE-FORMED STUCCO EXPANSION JOINT - CAULK JOINT CONTIN. MATCH SELECTED STUCCO COLOR.
12	DOWNSPOUT (DS): 24 ga. 3" x 4" PRE-FORMED, PRE-FIN. STEEL DOWNSPOUTS - COLOR TO BE SELECTED FROM MANUF. FULL RANGE.
13	4x4x4 BRICK ROWLOCK COURSE.
14	DOWNSPOUT RECEPTORS: ALL DOWNSPOUTS SHALL CONNECT INTO 3" DIA. PVC DRAIN RUNOUT PIPE with PVC BELL-SHAPED DOWNSPOUT RECEPTOR and TEE CONNECT INTO 4" DIA. PVC DRAIN PIPE - SLOPE UNDERGROUND DRAIN PIPE FROM 12" BELOW GRADE at 1/8" per FOOT and DAYLIGHT INTO LANDSCAPE AREA OR CONC. V-PAN, RE: SITE PLAN.
15	PRE-MOLDED MASONRY CONTROL JOINT.
16	CONTINUOUS CAULK AROUND PERIMETER OF DOOR FRAME, TYP.
17	CONTINUOUS CAULK AROUND PERIMETER OF WINDOW FRAME, TYP.
18	BUILDING ADDRESS NUMBERS: 5" H. ALUM. PRE-FINISHED BUILDING IDENTIFICATION (ADDRESS NUMBERS and LETTER). RE: SPECS.
19	MAKE-UP AIR LOUVER. RE: MECHANICAL for TYPE and SIZE.
20	DORM UNIT NUMBERS: 3" H. ALUM. PRE-FINISHED UNIT IDENTIFICATION (LETTER and NUMBERS). RE: SPECIFICATION SECTION 101410.
21	KNOX BOX: SUPPLIED BY OWNER, INSTALLED BY GENERAL CONTRACTOR. VERIFY WITH LOCAL FIRE DEPARTMENT FOR EXACT LOCATION and HEIGHT.

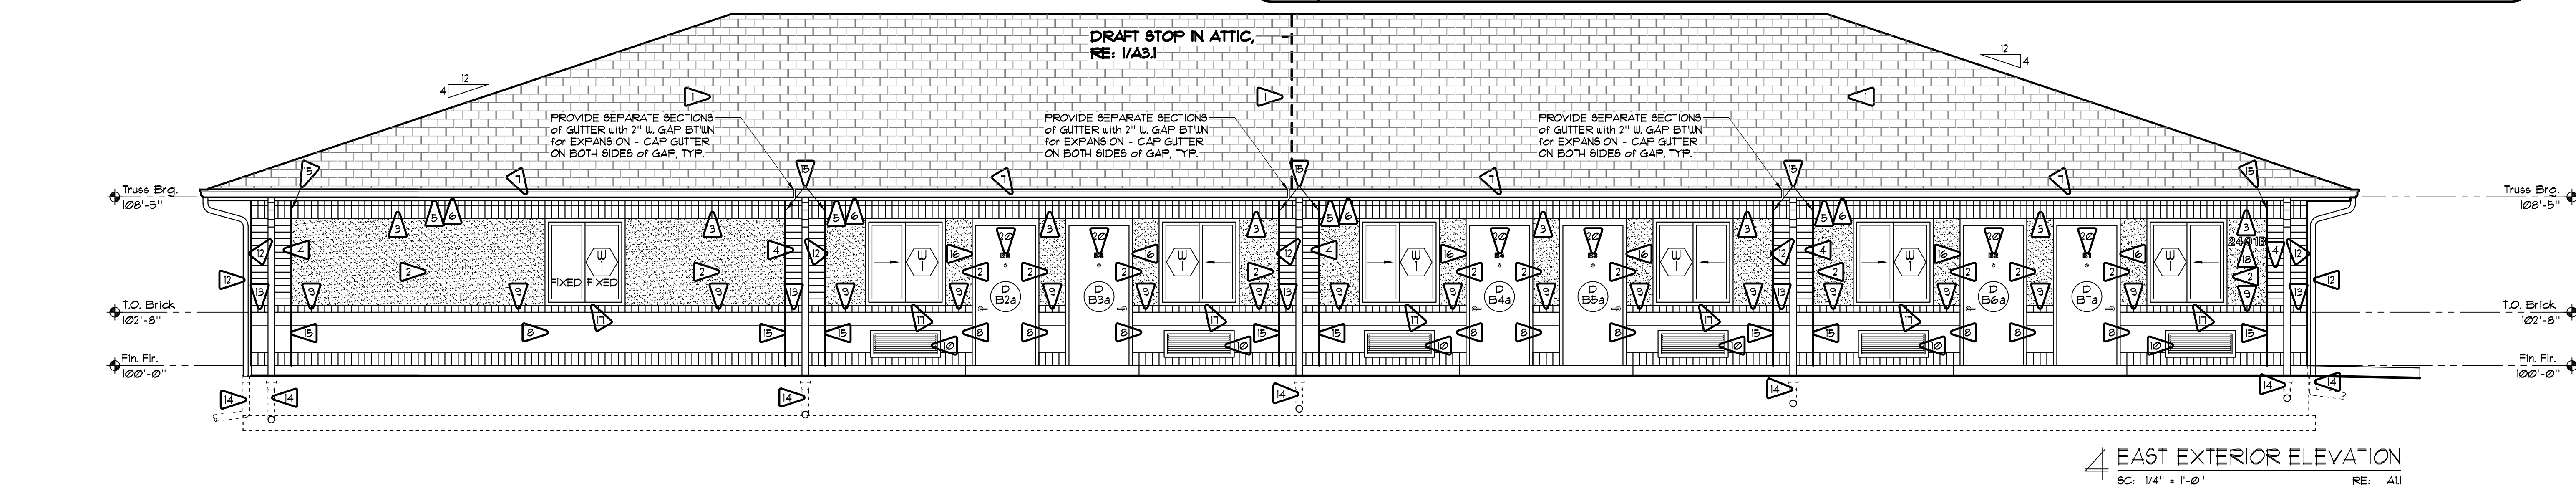


HIGFARCHITECTS

2602 N. ELIZABETH ST.
PUEBLO, COLORADO 81003
PH: (719) 543-7600
FX: (719) 545-2910
WEB: HGFARCH.COM

LAMAR COMMUNITY COLLEGE
NEW DORMITORY - BUILDING B - PHASE 1
2601 S. MAIN STREET LAMAR, COLORADO 81052

DATE: 05-31-12
DRAWN: CR / EK
CHECK: CR
REVISIONS:


SHEET
A2.1

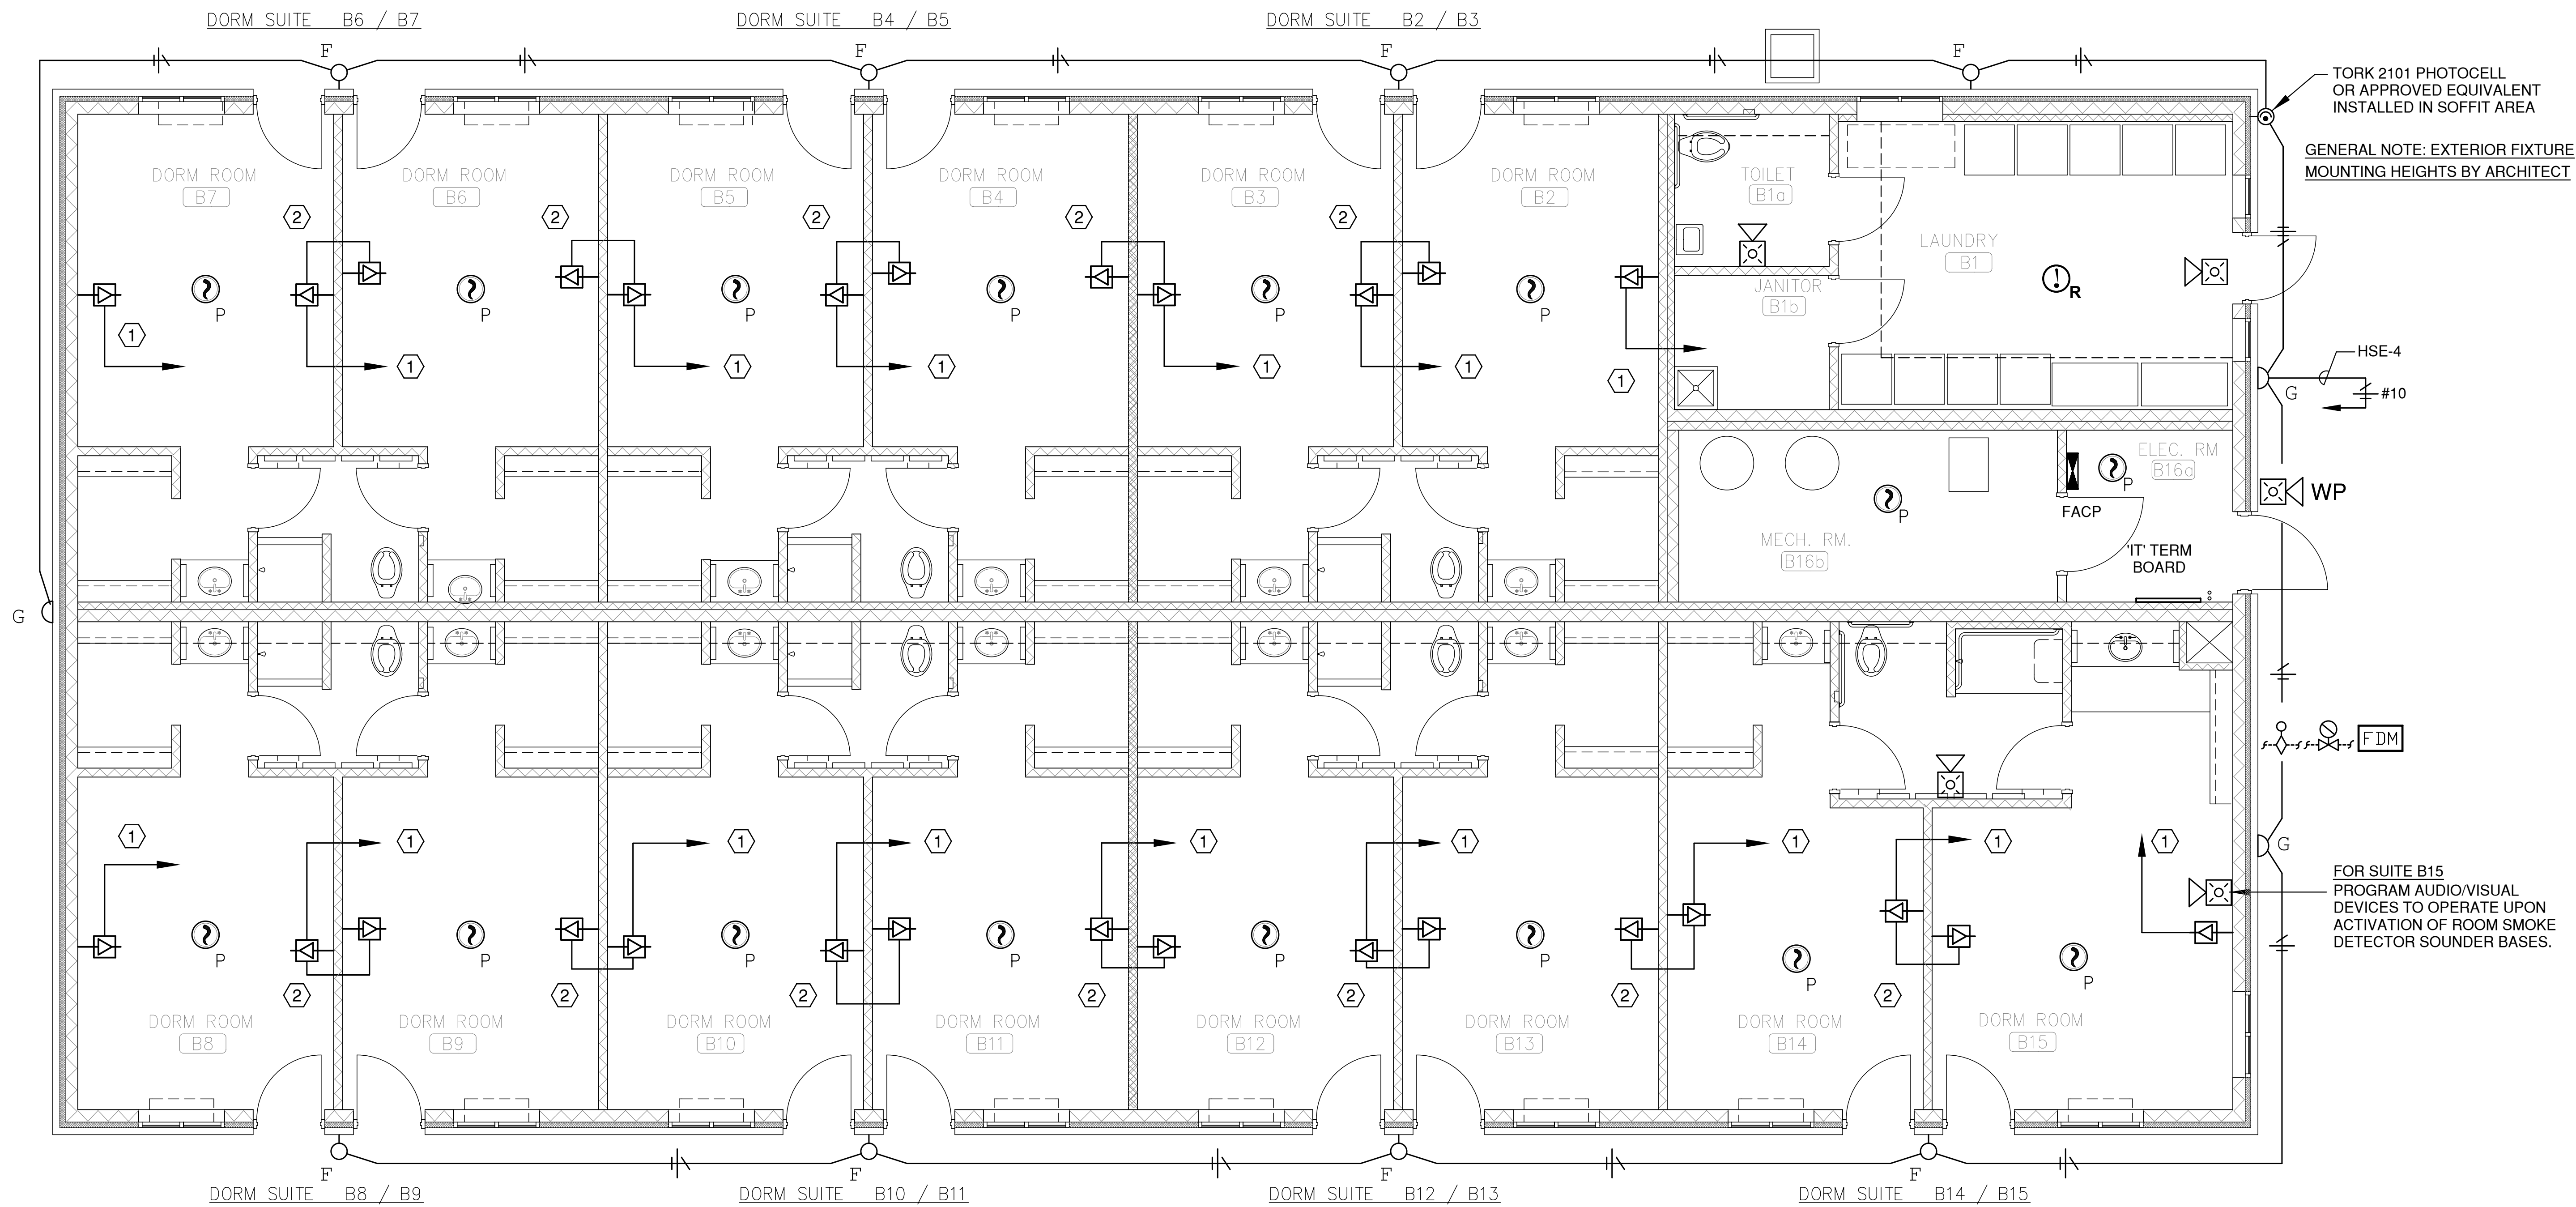

DORM - LV SYSTEMS & EXT LTG PLAN

SCALE: 1/4" = 1'- 0"

0 2' 4' 8'

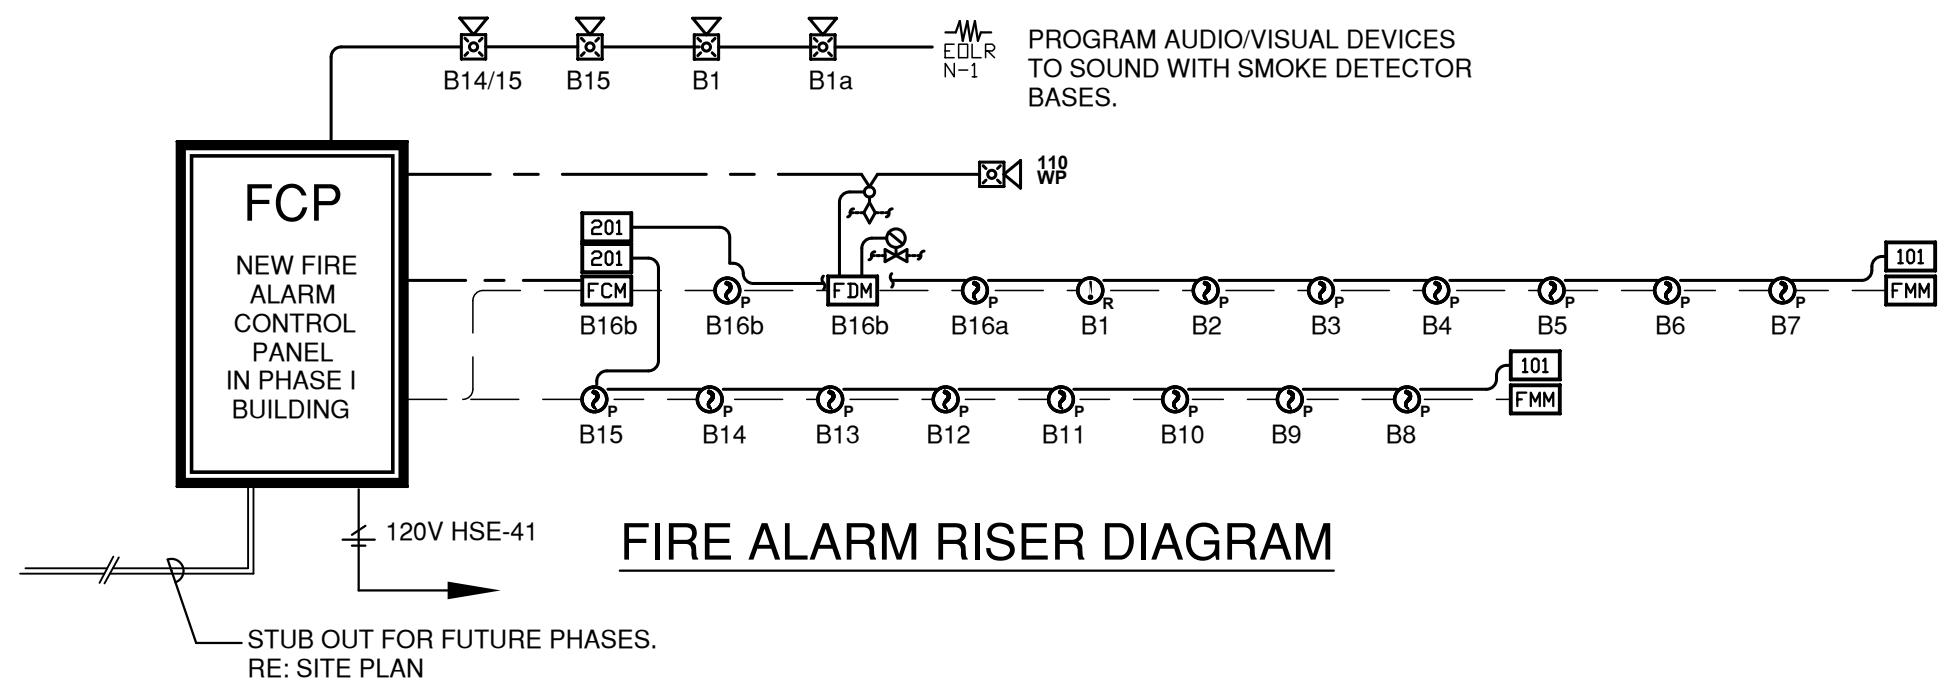

FIRE ALARM LEGEND		
SYMBOL	DESCRIPTION	MANUFACTURER PART
	FIELD CHARGER/POWER SUPPLY	NOTIFIER FCP5-24S6, BAT-12180
	ADDRESSABLE HEAT DETECTOR	NOTIFIER FST-851R, B710LP
	ADDRESSABLE SMOKE DETECTOR	NOTIFIER FSP-851, B710LP
	ADDRESSABLE SMOKE DETECTOR WITH SOUNDER BASE	NOTIFIER FSP-851, B501BH
	ADDRESSABLE DUAL MONITOR MODULE	NOTIFIER FDM-1
	ADDRESSABLE MINI MONITOR MODULE	NOTIFIER FMM-101
	ADDRESSABLE CONTROL MODULE	NOTIFIER FCM-1
	POWER SUPERVISION RELAYS	NOTIFIER A77-716B
	POLARITY REVERSAL RELAYS	SPACE AGE ELECT. MR-201
	WATER FLOW SWITCH	BY OTHERS
	TAMPER SWITCH	BY OTHERS
	HORN/STROBE, MULT-CANDELA - WALL MOUNT	NOTIFIER P2R
	HORN/STROBE FOR EXTERIOR USE, MULT-CANDELA	NOTIFIER P2R-K

FIRE ALARM SYSTEM NOTES:

- THE EQUIPMENT SUPPLIER SHALL BE 'CSSC' SOUTHERN COLORADO OFFICE 4186 CENTER PARK DRIVE COLORADO SPRINGS, COLORADO PH: (719) 638-7564 - FX: (719) 638-7914
- INSTALLER TO HAVE A NICET LEVEL 4 CERTIFICATION.
- THE SYSTEM VENDOR IS TO FURNISH FINAL INSTALLATION SHOP DRAWINGS AND PRODUCT DATA FOR APPROVAL. THESE DRAWINGS ARE TO INCLUDE ALL THE NECESSARY INFORMATION REQUIRED FOR PERMITTING AND CONTRACTOR INSTALLATION.
- THE SYSTEM VENDOR TO PROVIDE FINAL CONNECTIONS AND SYSTEM TESTING WITH A WRITTEN REPORT TO STATE CONDITION OF THE SYSTEM UPON ACCEPTANCE OF THE OWNER'S REPRESENTATIVE.
- ALL FIRE ALARM SYSTEM CABLING SHALL BE INSTALLED IN A COMPLETE RACEWAY SYSTEM.
- THE RACEWAY SYSTEM SHALL BE INSTALLED CONCEALED THROUGH OUT WITH THE EXCEPTION OF THE ELECTRICAL ROOM 'B16a'

'IT' SYMBOL LEGEND

ROUGH-IN ONLY FOR INFORMATION TECHNOLOGY DEVICES. PROVIDE A FLUSH 4S BOX WITH TWO GANG RING AND BLANK COVER PLATE. PROVIDE CONDUITS AND PULL STRINGS AS INDICATED IN WORK NOTES. ALL 'IT' DEVICES AND CABLING (NIC)

- WORK NOTES: (THIS SHEET ONLY)
- 1" ROUTED CONCEALED IN ATTIC SPACE AND STUBBED DOWN 6" FROM CEILING AT 'IT' TERMINAL BOARD. PROVIDE PULLSTRING AND INSULATED BUSHING ON STUB END OF CONDUIT. TAG EACH STRING TO WALL SERVED (I.E. EAST WALL B15 OR EASTWEST WALL OF B15/B14.
- 1" TIE BETWEEN 'IT' DEVICE ROUGH-IN BOXES.

Z:\2011\2011.043\ 2011.043 Elec Final Set 05-31-12.dwg Jun 06, 2012 - 10:40am

DATE
31 May 2012
DRAWN
MSK
CHECK
LMAK
REVISIONS:

SHEET
E2.1

OVERALL - SYSTEMS AND EXTERIOR LIGHTING PLAN

LAMAR COMMUNITY COLLEGE
NEW DORMITORY - BUILDING B - PHASE 1
2401 S. MAIN STREET LAMAR, COLORADO

HIGLEY ARCHITECTS
2602 N. ELIZABETH ST.
PUEBLO, COLORADO 81003
PH: (719) 543-7600
FX: (719) 545-2910
WEB: HGFARCH.COM

Robert Electrical Engineers, Inc.
811 South 8th Street, Colorado Springs Co. 80906
Phone: (719) 596-8600
Email Address: email@robnet.com